

Genentech

A Member of the Roche Group

BUILDING 09 - 640 FORBES BLVD, SOUTH SAN FRANCISCO, CA 94080

SSF BUILDING 09 AT&T ANTENNA RELOCATION
GNE PROJECT NUMBER - L160.77412

ISSUE FOR PERMIT - 01.24.2024

PROJECT DATA

OCCUPANCY TYPE(S):	B
CONSTRUCTION TYPE:	III-B
PROPOSED USE:	B (NO CHANGE)
AREA OF IMPROVEMENTS:	N/A
LEGAL DESCRIPTION: PARCEL MAP 15-23 IN THE CITY OF SOUTH SAN FRANCISCO, COUNTY OF SAN MATEO, STATE OF CALIFORNIA	
ASSESSORS PARCEL NO. (APN):	015-232-500
ZONING:	GMPD
CITY PLAN CHECK NO.:	T.B.D.
THIRD PARTY PLAN CHECK NO.:	T.B.D.

GOVERNING CODES

CALIFORNIA CODE OF REGULATIONS TITLE 24, INCLUDING ALL AMENDMENTS:
PART 1: 2022 CALIFORNIA ADMINISTRATIVE CODE (CAC)
PART 2: 2022 CALIFORNIA BUILDING CODE (CBC)
PART 3: 2022 CALIFORNIA ELECTRICAL CODE (CEC)
PART 4: 2022 CALIFORNIA MECHANICAL CODE (CMC)
PART 5: 2022 CALIFORNIA PLUMBING CODE (CPC)
PART 6: 2022 CALIFORNIA ENERGY CODE
PART 9: 2022 CALIFORNIA FIRE CODE (CFC)
PART 11: 2022 CALIFORNIA GREEN BUILDING STANDARDS CODE
PART 12: 2022 CALIFORNIA REFERENCE STANDARDS CODE
CALIFORNIA CODE OF REGULATIONS, TITLE 8 (CAL OSHA)

OTHER REGULATIONS
BAY AREA AIR QUALITY MANAGEMENT DISTRICT (BAAQMD)
CITY OF **SOUTH SAN FRANCISCO** ADOPTED CODES, REGULATIONS AND ORDINANCES

ACCESSIBILITY
NON APPLICABLE

CAL-GREEN
EXEMPTED 2022 CALGREEN, SECTION 301.3, ALTERATION WITH PERMIT VALUATION OF \$200,000 OR LESS.

SPECIAL INSPECTIONS
1. SPECIAL INSPECTION AGENCY SELECTED SHALL BE RECOGNIZED BY THE CITY.
LINK TO LIST:
<https://www.ssf.net/departments/economic-community-development/building-division/handouts>
2. REFER TO STRUCTURAL, ELECTRICAL, AND PLUMING DRAWINGS FOR SPECIAL INSPECTIONS & OBSERVATIONS REQUIREMENTS.

PROJECT TEAM

OWNER
GENENTECH 1 DNA WAY SOUTH SAN FRANCISCO, CA 94080 TEL: 650.676.7136 CONTACT: SAM AL-MOHAMADI EMAIL: al-mohamadi.sam@genentech.com
ARCHITECT
DGA planning architecture interiors 755 SANSOME ST, 5TH FLOOR SAN FRANCISCO, CA 94111 TEL: 415.477.2700 CONTACT: SEAN QUACH EMAIL: squach@dga-mv.com

ELECTRICAL

AFFILIATED ENGINEERS, INC. 300 CALIFORNIA STREET, 6TH FLOOR SAN FRANCISCO, CA 94104 TEL: 415.764.3726 CONTACT: JENNER LAM EMAIL: jlam@aelieng.com
--

STRUCTURAL

SIMPSON GUMPERTZ & HEGER 1999 HARRISON STREET, SUITE 2400 OAKLAND, CA 94612 TEL: 415.343.3048 CONTACT: KENNETH T. TAM EMAIL: KTTam@sggh.com
--

GENERAL CONTRACTOR

XL CONSTRUCTION 1111 BROADWAY SUITE 2050 OAKLAND, CA 94607 TEL: 408.240.6027 MOBILE: 510.847.1842 CONTACT: DAVID WOOD EMAIL: dwood@xlconstruction.com

SCOPE OF WORK


THE SCOPE OF WORK CONSISTS OF RELOCATION OF (E) AT&T ANTENNA FROM BUILDING 50 ROOF TO BUILDING 9 ROOF.

DRAWING INDEX

DRAWING INDEX		ISSUE FOR PERMIT
DRAWING NO.	DRAWING NAME	
GENERAL		
109-A00-P001	COVER SHEET & DRAWING INDEX	■
109-A00-P002	LOCATION PLAN, EXTERIOR LINE-OF-SIGHT	■
ARCHITECTURAL		
109-A08-P001	WATERPROOFING DETAILS	■
STRUCTURAL		
109-S00-P001	GENERAL NOTES & ABBREVIATIONS	■
109-S00-P002	STRUCTURAL OBSERVATION & SPECIAL INSPECTIONS NOTES	■
109-S02-P001	PARTIAL ROOF EQUIPMENT SUPPORT PLAN	■
109-S07-P001	DETAILS	■
ELECTRICAL		
STD-E00-001-1	ELECTRICAL LEGEND, SYMBOLS AND ABBREVIATIONS	■
STD-E00-001-2	ELECTRICAL GENERAL NOTES, FEEDER SCHEDULE	■
109-E01-040	ELECTRICAL SINGLE LINE DIAGRAM HDP1C1	■
109-E01-044	ELECTRICAL SINGLE LINE DIAGRAM EHDP1C1 & EHDP2W1	■
109-E04-902	MASTER ELECTRICAL POWER + GROUNDING PLAN SECOND FL	■
109-E04-903	MASTER ELECTRICAL - GROUNDING PLAN ROOF	■
109-E04-P102	PARTIAL ELECTRICAL PLAN SECOND FLOOR	■
109-E04-P103	PARTIAL ELECTRICAL PLAN ROOF	■
109-E05-038	ELECTRICAL PANEL SCHEDULES	■
109-E05-902-2	MASTER PANEL SCHEDULES DISTRIBUTION CIRCUIT HDP1C1	■
109-E05-902-3	MASTER PANEL SCHEDULES DISTRIBUTION CIRCUIT HDP1C1	■
109-E06-P101	ELECTRICAL DETAIL	■
TOTAL SHEETS: 19		

DRAWING NUMBER SYSTEM

DRAWING NUMBERING ARE PER GENENTECH DESIGN DOCUMENT CONVENTIONS (SRD-0106853 V8.0)

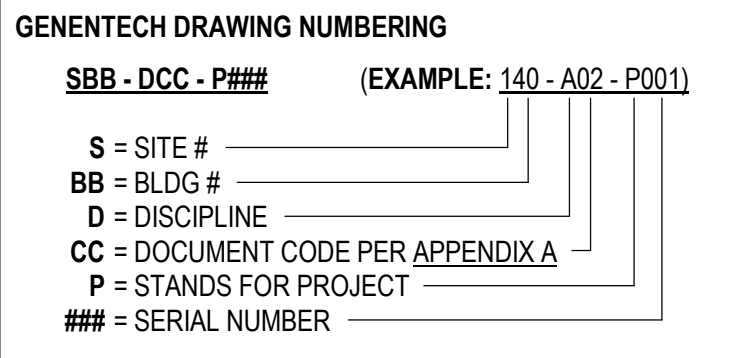

D - DISCIPLINE (SBB - DCC - P###)


A	ARCHITECTURE
C	CIVIL
D	PROCESS DESIGN
E	ELECTRICAL
F	FIRE PROTECTION (SPRINKLER SYSTEMS & SPECIAL HAZARD SYSTEMS)
G	GENERAL
I	INSTRUMENTATION
L	LANDSCAPING
M	MECHANICAL (HVAC, WET & DRY)
P	PIPING / PLUMBING
Q	EQUIPMENT
S	STRUCTURAL
W	ENVIRONMENTAL
X	OTHER
Y	MODULES & SKIDS (VENDOR DRAWINGS)
Z	CONTRACTOR / SHOP DRAWINGS

CC - DOCUMENT CODE (SBB - DCC - P###)

NOTE: ONLY ARCHITECTURE DOCUMENT CODE IS REFERENCED BELOW. FOR DOCUMENT CODE OF OTHER DISCIPLINES, REFER TO APPENDIX A OF GENENTECH DESIGN DOCUMENT CONVENTIONS (SRD-0106853 V8.0)

A00	GENERAL (INDEX, SYMBOLS, ABBREVIATIONS, NOTES, REFERENCES, LOCATION MAP), BUILDING CODE LIFE SAFETY INFORMATION
A01	SITE PLAN
A02	FLOOR PLANS (MAY BE USED FOR LOCATION RELATED DRAWINGS SUCH AS FIRE EXTINGUISHER LOCATIONS OR OTHER LOCATION MAPS REQUIRING THE USE OF A FLOOR PLAN)
A03	SECTIONS, EXTERIOR ELEVATIONS
A04	FURNITURE PLAN
A05	INTERIOR ELEVATIONS
A06	REFLECTED CEILING PLANS
A07	VERTICAL CIRCULATION, STAIRS, (ELEVATORS, ESCALATORS)
A08	EXTERIOR DETAILS
A09	INTERIOR DETAILS
A10	EQUIPMENT PLAN (LAB AND FOOD SERVICE EQUIPMENT)
A11	SIGNS
A12	REGULATORY MAPS
A13	INFORMATIONAL PURPOSES ONLY
A14	3-D MODELS
A15	DOOR & WINDOW SCHEDULES, DETAILS
A16	ROOM MATERIAL SCHEDULE, FINISH PLAN OR SCHEDULE, KEY DRAWINGS

VICINITY MAP

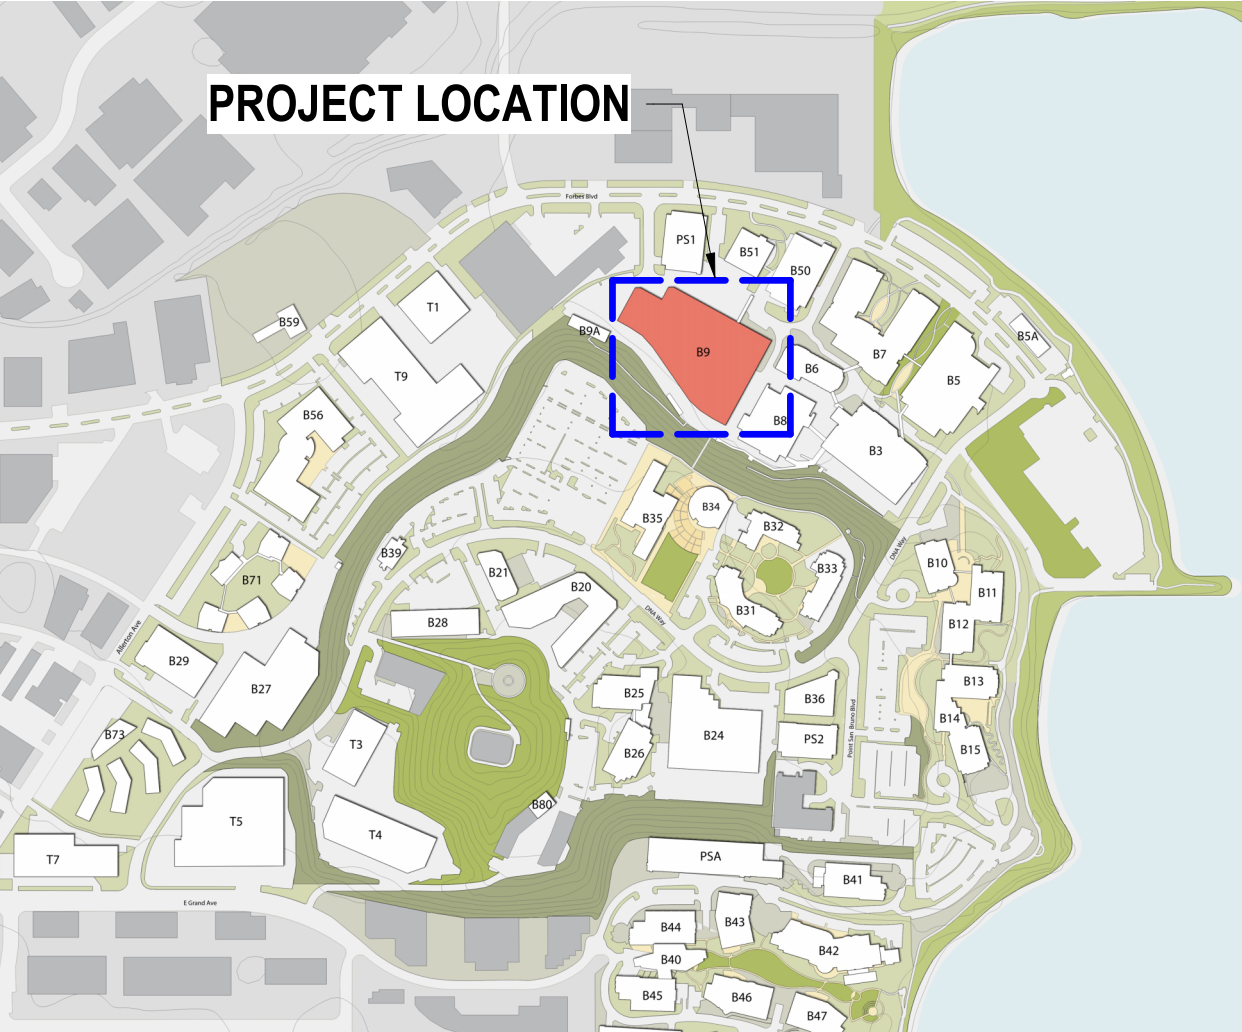

PROJECT LOCATION



Genentech

A Member of the Roche Group


SCALE: 1/2" = 1'-0"

This drawing is the property of Genentech. The information is confidential and is to be used only in connection with work directed by Genentech. No part of this drawing is to be disclosed to others without written permission from Genentech.


TITLE: GENERAL
COVER SHEET & DRAWING INDEX
BUILDING 09 AT&T ANTENNA RELOCATION



DRAWING NUMBER: 109-A00-P001

REV: A

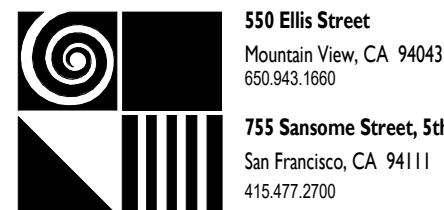

DGA | planning | architecture | interiors

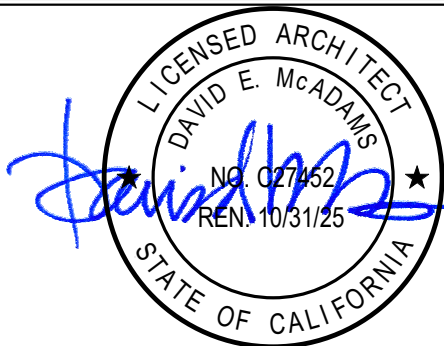

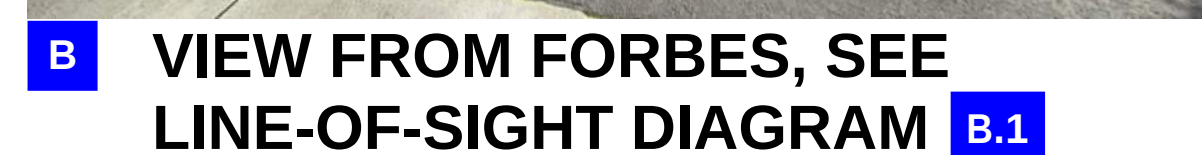 


LINE-OF-SIGHT
NOTE TO PLAN CHECKER, RELOCATED
ANTENNA IS PLACED AWAY FROM PUBLIC
VIEWS; THESE VIEWS ARE FOR ILLUSTRATION
TO SHOW COMPLIANCE



PROPOSED ANTENNA LOCATIONS (B09 & B06)



drawing is to be disclosed to others without written permission from Genitech.																
VENDOR DRAWING NO.: 23297		NO.	REVISION DESCRIPTION	BY	DATE	APPR	DATE	NO.	REVISION DESCRIPTION	BY	DATE	APPR	DATE	DESIGNERS/APPROVERS	DATE	TITLE: FILENAME:
 550 Ellis Street Pleasant View, CA 94043 650.515.1000 755 Sansome Street, 5th Floor San Francisco, CA 94111 415.477.2790 DGA planning architecture interiors								A	ISSUE FOR PERMIT	DGA	01/24/25	-	-	DESIGNED BY:		GENERAL
														DRAWN BY:		LOCATION PLAN, EXTERIOR LINE-OF-SIGHT
														APPROVED BY:		.
														APPROVED BY:		BUILDING 09 AT&T ANTENNA RELOCATION
														CONDOR DOC. NO.: N/A	DRAWING NUMBER: 109-A00-P002	REV.: A

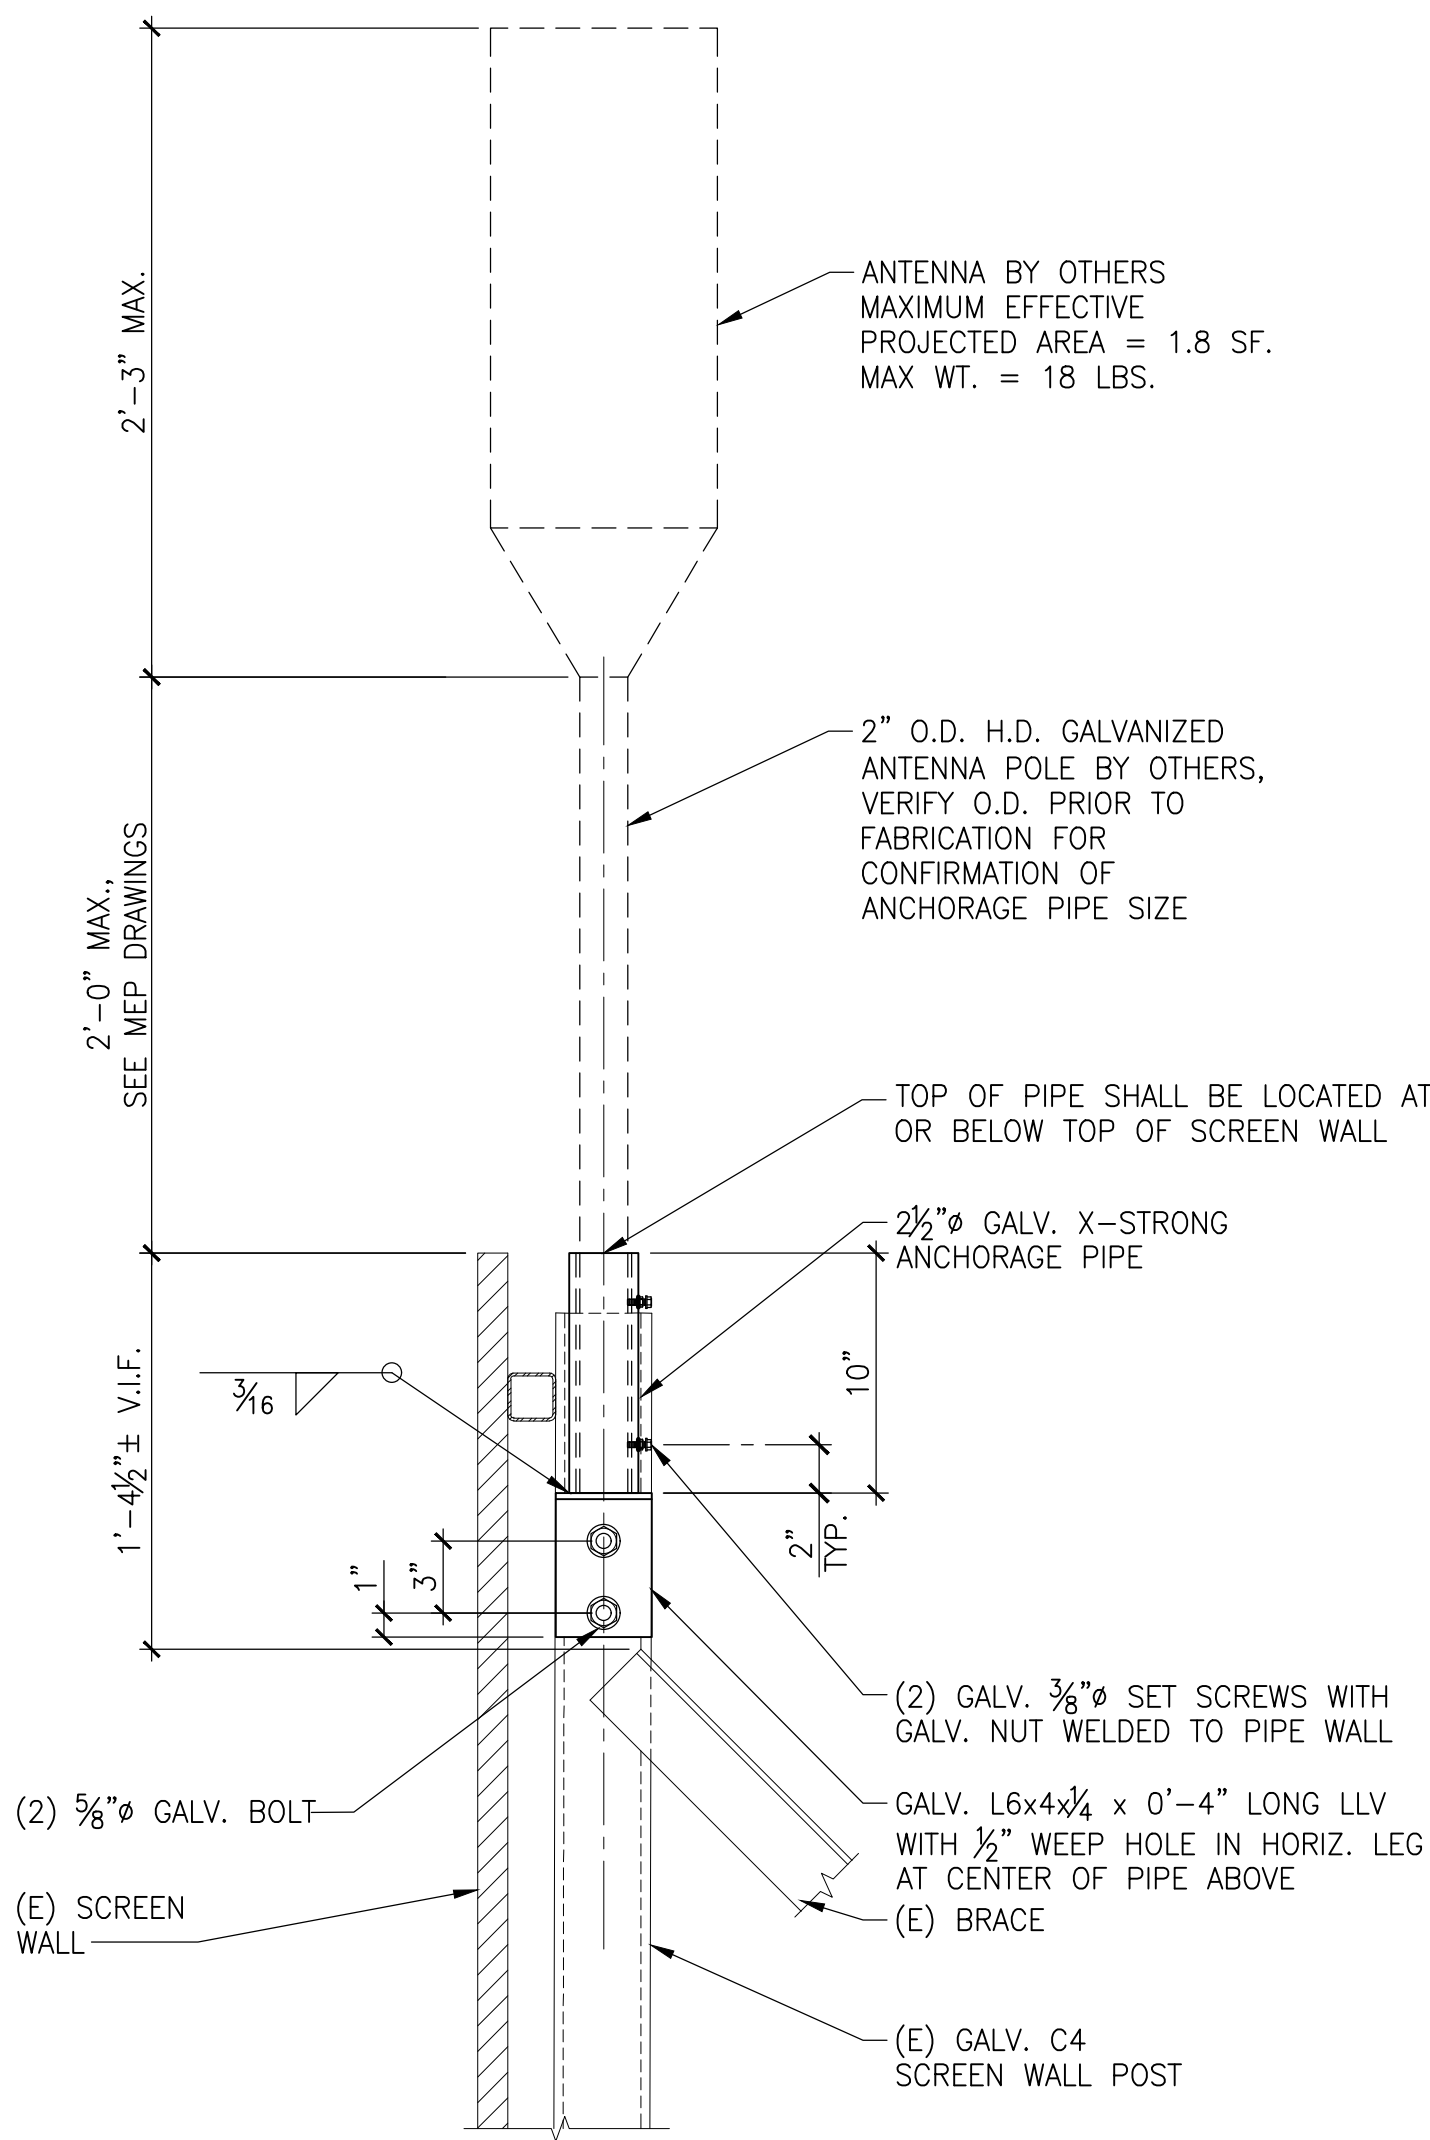

6 ANTENNA POLE ANCHORAGE DETAIL AT TOP OF SCREEN WALL SCALE: 1 1/2"=1'-0"

REFERENCE DRAWING(S):

Genentech
A Member of the Roche Group

This drawing is the property of Genentech. The information is confidential and is to be used only in connection with work directed by Genentech. No part of this drawing is to be disclosed to others without written permission from Genentech.

SCALE: NONE
1 DNA WAY
SOUTH SAN FRANCISCO, CA

TITLE: STRUCTURAL DETAILS
BUILDING 09 AT&T ANTENNA RELOCATION

FILENAME: 109-S07-P001

CONDOR DOC. NO.: N/A

DRAWING NUMBER: 109-S07-P001
REV.: A

VENDOR DRAWING NO.: N/A


SGH
SIMPSON GUMPERTZ & HEGER
1999 Harrison Street, Suite 2400
Oakland, CA 94612
415.495.3700
sgH.com

REGISTERED PROFESSIONAL ENGINEER
No. 45559
DATE SIGNED: 7/24/25
STRUCTURAL
STATE OF CALIFORNIA

NO.	REVISION DESCRIPTION	BY	DATE	APPR	DATE	NO.	REVISION DESCRIPTION	BY	DATE	APPR	DATE
						A	ISSUE FOR PERMIT	SGH	01/24/25		


AEI Affiliated Engineers
Affiliated Engineers, Inc.
300 California Street, 6th floor
San Francisco, California 94104
415.764.3700

109-S07-P001-2024

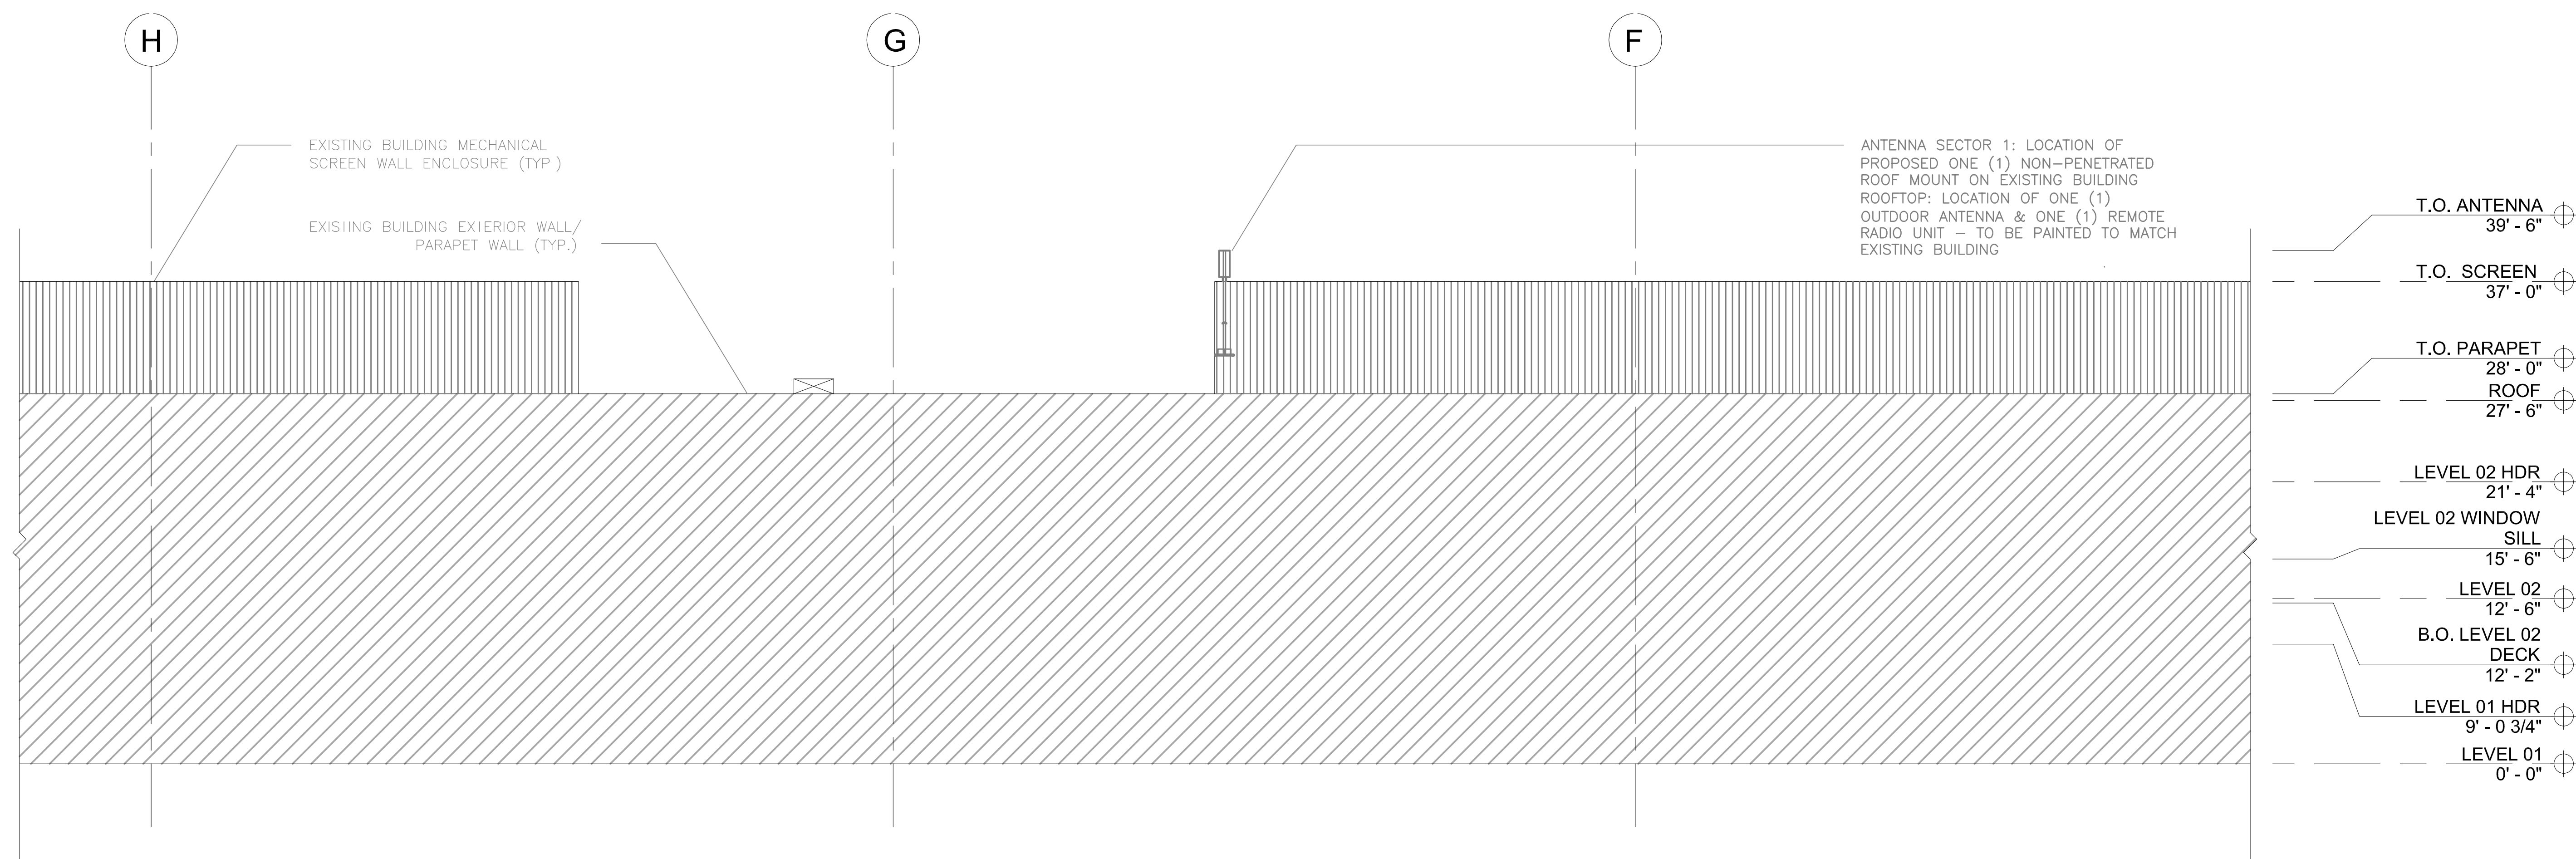

I PARTIAL EXTERIOR ELEVATION, NORTH

Genentech <i>A Member of the Roche Group</i>		SC ALE:	
This drawing is the property of Genentech. The information is confidential and is to be used only in connection with work directed by Genentech. No part of this drawing is to be disclosed to others without written permission from Genentech.			
TITLE:		FILENAME:	
ARCHITECTURAL			
PARTIAL EXTERIOR ELEVATION, NORTH			
BUILDING 09 AT&T ANTENNA RELOCATION			
DRAWING NUMBER:	109-A03-P001	REV.: D	

 VENDOR DRAWING NO.: 23297		NO.	REVISION	DESCRIPTION	BY	DATE	APPR	DATE	NO.	REVISION	DESCRIPTION	BY	DATE	APPR	DATE	DESIGNERS/APPROVERS	DATE
 559 Ellis Street Houston, TX, CA 9043 650.943.9090 755 Sansome Street, 5th Floor San Francisco, CA 94111 415.477.2700 DGA planning architecture interiors 									D		PLAN CHECK RESPONSE	DGA	04/28/25	-	-	DESIGNED BY:	
																DRAWN BY:	
																APPROVED BY:	
																APPROVED BY:	
																	CONDOR DOC. NO.: N/A