



A Member of the Roche Group

BUILDING 06 - 660 FORBES BLVD, SOUTH SAN FRANCISCO, CA 94080

SSF BUILDING 06 AT&T ANTENNA RELOCATION

GNE PROJECT NUMBER - L160.77412

ISSUE FOR PERMIT - 01.24.2024

PROJECT DATA

OCCUPANCY TYPE(S):	B
CONSTRUCTION TYPE:	I-B
PROPOSED USE:	F1 (LEVEL 1 ONLY, NO CHANGE) B (NO CHANGE)
AREA OF IMPROVEMENTS:	N/A
LEGAL DESCRIPTION:	PARCEL MAP 15-23 IN THE CITY OF SOUTH SAN FRANCISCO, COUNTY OF SAN MATEO, STATE OF CALIFORNIA
ASSESSORS PARCEL NO. (APN):	015-232-500
ZONING:	GMPD
CITY PLAN CHECK NO.:	T.B.D.
THIRD PARTY PLAN CHECK NO.:	T.B.D.

GOVERNING CODES

CALIFORNIA CODE OF REGULATIONS TITLE 24, INCLUDING ALL AMENDMENTS:

- PART 1: 2022 CALIFORNIA ADMINISTRATIVE CODE (CAC)
- PART 2: 2022 CALIFORNIA BUILDING CODE (CBC)
- PART 3: 2022 CALIFORNIA ELECTRICAL CODE (CEC)
- PART 4: 2022 CALIFORNIA MECHANICAL CODE (CMC)
- PART 5: 2022 CALIFORNIA PLUMBING CODE (CPC)
- PART 6: 2022 CALIFORNIA ENERGY CODE
- PART 9: 2022 CALIFORNIA FIRE CODE (CFC)
- PART 11: 2022 CALIFORNIA GREEN BUILDING STANDARDS CODE
- PART 12: 2022 CALIFORNIA REFERENCE STANDARDS CODE
- CALIFORNIA CODE OF REGULATIONS, TITLE 8 (CAL OSHA)

OTHER REGULATIONS

BAY AREA AIR QUALITY MANAGEMENT DISTRICT (BAAQMD)
CITY OF **SOUTH SAN FRANCISCO** ADOPTED CODES, REGULATIONS AND ORDINANCES

ACCESSIBILITY

NON APPLICABLE

CAL-GREEN

EXEMPTED 2022 CALGREEN, SECTION 301.3, ALTERATION WITH PERMIT VALUATION OF \$200,000 OR LESS.

SPECIAL INSPECTIONS

- SPECIAL INSPECTION AGENCY SELECTED SHALL BE RECOGNIZED BY THE CITY.
LINK TO LIST:
<https://www.ssf.net/departments/economic-community-development/building-division/handouts>
- REFER TO STRUCTURAL, ELECTRICAL, AND PLUMING DRAWINGS FOR SPECIAL INSPECTIONS & OBSERVATIONS REQUIREMENTS.

PROJECT TEAM

OWNER


GENENTECH
1 DNA WAY
SOUTH SAN FRANCISCO, CA 94080

TEL: 650.676.7136
CONTACT: SAM AL-MOHAMADI
EMAIL: al-mohamadi.sam@genentech.com

ARCHITECT

DGA planning | architecture | interiors
755 SANSOME ST, 5TH FLOOR
SAN FRANCISCO, CA 94111

TEL: 415.477.2700
CONTACT: SEAN QUACH
EMAIL: squach@dga-mv.com

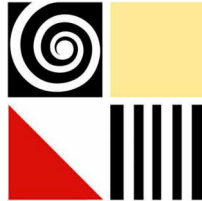

ELECTRICAL

AFFILIATED ENGINEERS, INC.

300 CALIFORNIA STREET, 6TH FLOOR
SAN FRANCISCO, CA 94104

TEL: 415.764.3726
CONTACT: JENNER LAM
EMAIL: jlam@aeeieng.com

STRUCTURAL

SIMPSON GUMPERTZ & HEGER

1999 HARRISON STREET, SUITE 2400
OAKLAND, CA 94612

TEL: 415.343.3048
CONTACT: KENNETH T. TAM
EMAIL: KTTam@sggh.com

GENERAL CONTRACTOR

XL CONSTRUCTION

1111 BROADWAY SUITE 2050
OAKLAND, CA 94607

TEL: 408.240.6027
MOBILE: 510.847.1842
CONTACT: DAVID WOOD
EMAIL: dwood@xlconstruction.com

SCOPE OF WORK


THE SCOPE OF WORK CONSISTS OF RELOCATION OF (E) AT&T ANTENNA FROM BUILDING 50 ROOF TO BUILDING 6 ROOF.

DRAWING INDEX

DRAWING INDEX		ISSUE FOR PERMIT
DRAWING NO.	DRAWING NAME	
GENERAL		
106-A00-P001	COVER SHEET & DRAWING INDEX	■
106-A00-P002	LOCATION PLAN, EXTERIOR LINE-OF-SIGHT	■
ARCHITECTURAL		
106-A08-P001	WATERPROOFING DETAILS	■
STRUCTURAL		
106-S00-P001	GENERAL NOTES & ABBREVIATIONS	■
106-S00-P002	STRUCTURAL OBSERVATION & SPECIAL INSPECTIONS NOTES	■
106-S02-P001	PARTIAL ROOF EQUIPMENT SUPPORT PLAN	■
106-S07-P001	DETAILS	■
ELECTRICAL		
STD-E00-001-1	ELECTRICAL LEGEND, SYMBOLS AND ABBREVIATIONS	■
STD-E00-001-2	ELECTRICAL GENERAL NOTES, FEEDER SCHEDULE	■
106-E01-201	ELECTRICAL POWER RISER DIAGRAM	■
106-E04-902	MASTER ELECTRICAL AND GROUNDING PLAN SECOND FL	■
106-E04-903	MASTER ELECTRICAL AND GROUNDING PLAN THIRD FL	■
106-E04-904	MASTER ELECTRICAL AND GROUNDING PLAN FOURTH FL	■
106-E04-905	MASTER ELECTRICAL AND GROUNDING PLAN FIFTH FL	■
106-E04-906	MASTER ELECTRICAL AND GROUNDING PLAN ROOF/PENTHOUSE	■
106-E04-P106	PARTIAL ELECTRICAL PLAN ROOF/PENTHOUSE	■
106-E05-901-2	MASTER PANEL SCHEDULE DISTRIBUTION CIRCUIT HDPO6A1	■
106-E05-906	MASTER PANEL SCHEDULE DISTRIBUTION CIRCUIT UHDP06A1	■
106-E06-P101	ELECTRICAL DETAIL	■
TOTAL SHEETS: 19		

DRAWING NUMBER SYSTEM

DRAWING NUMBERING ARE PER GENENTECH DESIGN DOCUMENT CONVENTIONS (SRD-0106853 V8.0)

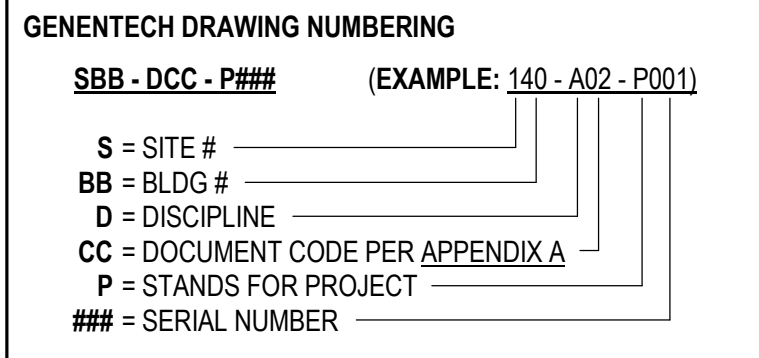

D - DISCIPLINE (SBB - DCC - P###)


- A ARCHITECTURE
- C CIVIL
- D PROCESS DESIGN
- E ELECTRICAL
- F FIRE PROTECTION (SPRINKLER SYSTEMS & SPECIAL HAZARD SYSTEMS)
- G GENERAL
- I INSTRUMENTATION
- L LANDSCAPING
- M MECHANICAL (HVAC, WET & DRY)
- P PIPING / PLUMBING
- Q EQUIPMENT
- S STRUCTURAL
- W ENVIRONMENTAL
- X OTHER
- Y MODULES & SKIDS (VENDOR DRAWINGS)
- Z CONTRACTOR / SHOP DRAWINGS

CC - DOCUMENT CODE (SBB - DCC - P###)

NOTE: ONLY ARCHITECTURE DOCUMENT CODE IS REFERENCED BELOW. FOR DOCUMENT CODE OF OTHER DISCIPLINES, REFER TO **APPENDIX A** OF GENENTECH DESIGN DOCUMENT CONVENTIONS (SRD-0106853 V8.0)

- A00 GENERAL (INDEX, SYMBOLS, ABBREVIATIONS, NOTES, REFERENCES, LOCATION MAP), BUILDING CODE LIFE SAFETY INFORMATION
- A01 SITE PLAN
- A02 FLOOR PLANS (MAY BE USED FOR LOCATION RELATED DRAWINGS SUCH AS FIRE EXTINGUISHER LOCATIONS OR OTHER LOCATION MAPS REQUIRING THE USE OF A FLOOR PLAN)
- A03 SECTIONS, EXTERIOR ELEVATIONS
- A04 FURNITURE PLAN
- A05 INTERIOR ELEVATIONS
- A06 REFLECTED CEILING PLANS
- A07 VERTICAL CIRCULATION, STAIRS, (ELEVATORS, ESCALATORS)
- A08 EXTERIOR DETAILS
- A09 INTERIOR DETAILS
- A10 EQUIPMENT PLAN (LAB AND FOOD SERVICE EQUIPMENT)
- A11 SIGNS
- A12 REGULATORY MAPS
- A13 INFORMATIONAL PURPOSES ONLY
- A14 3-D MODELS
- A15 DOOR & WINDOW SCHEDULES, DETAILS
- A16 ROOM MATERIAL SCHEDULE, FINISH PLAN OR SCHEDULE, KEY DRAWINGS

VICINITY MAP

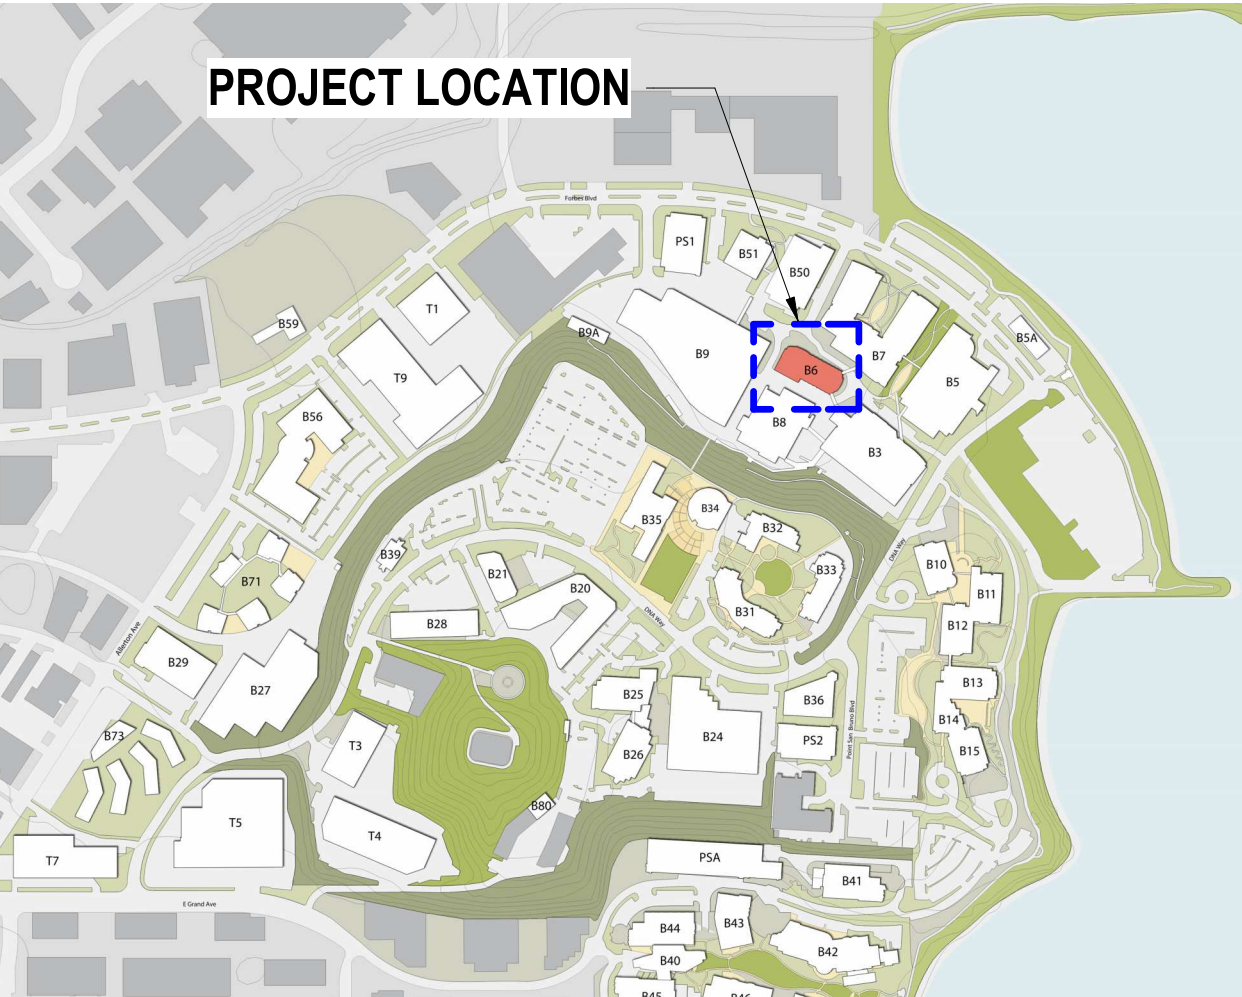

PROJECT LOCATION




Genentech

A Member of the Roche Group


SCALE: 1/2" = 1'-0"


This drawing is the property of Genentech. The information is confidential and is to be used only in connection with work directed by Genentech. No part of this drawing is to be disclosed to others without written permission from Genentech.

TITLE:	FILENAME:
GENERAL COVER SHEET & DRAWING INDEX	
BUILDING 06 AT&T ANTENNA RELOCATION	
DRAWING NUMBER:	106-A00-P001
REV.:	A

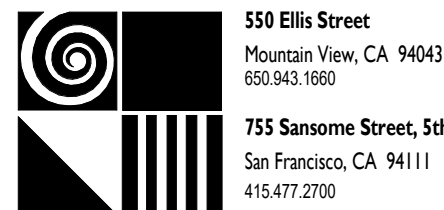

DGA | planning | architecture | interiors

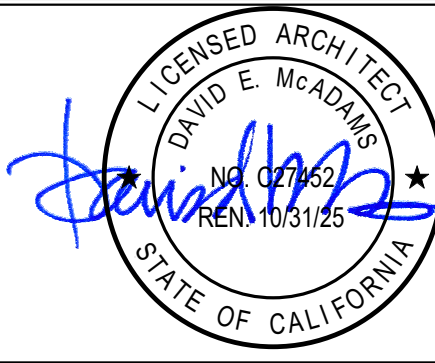

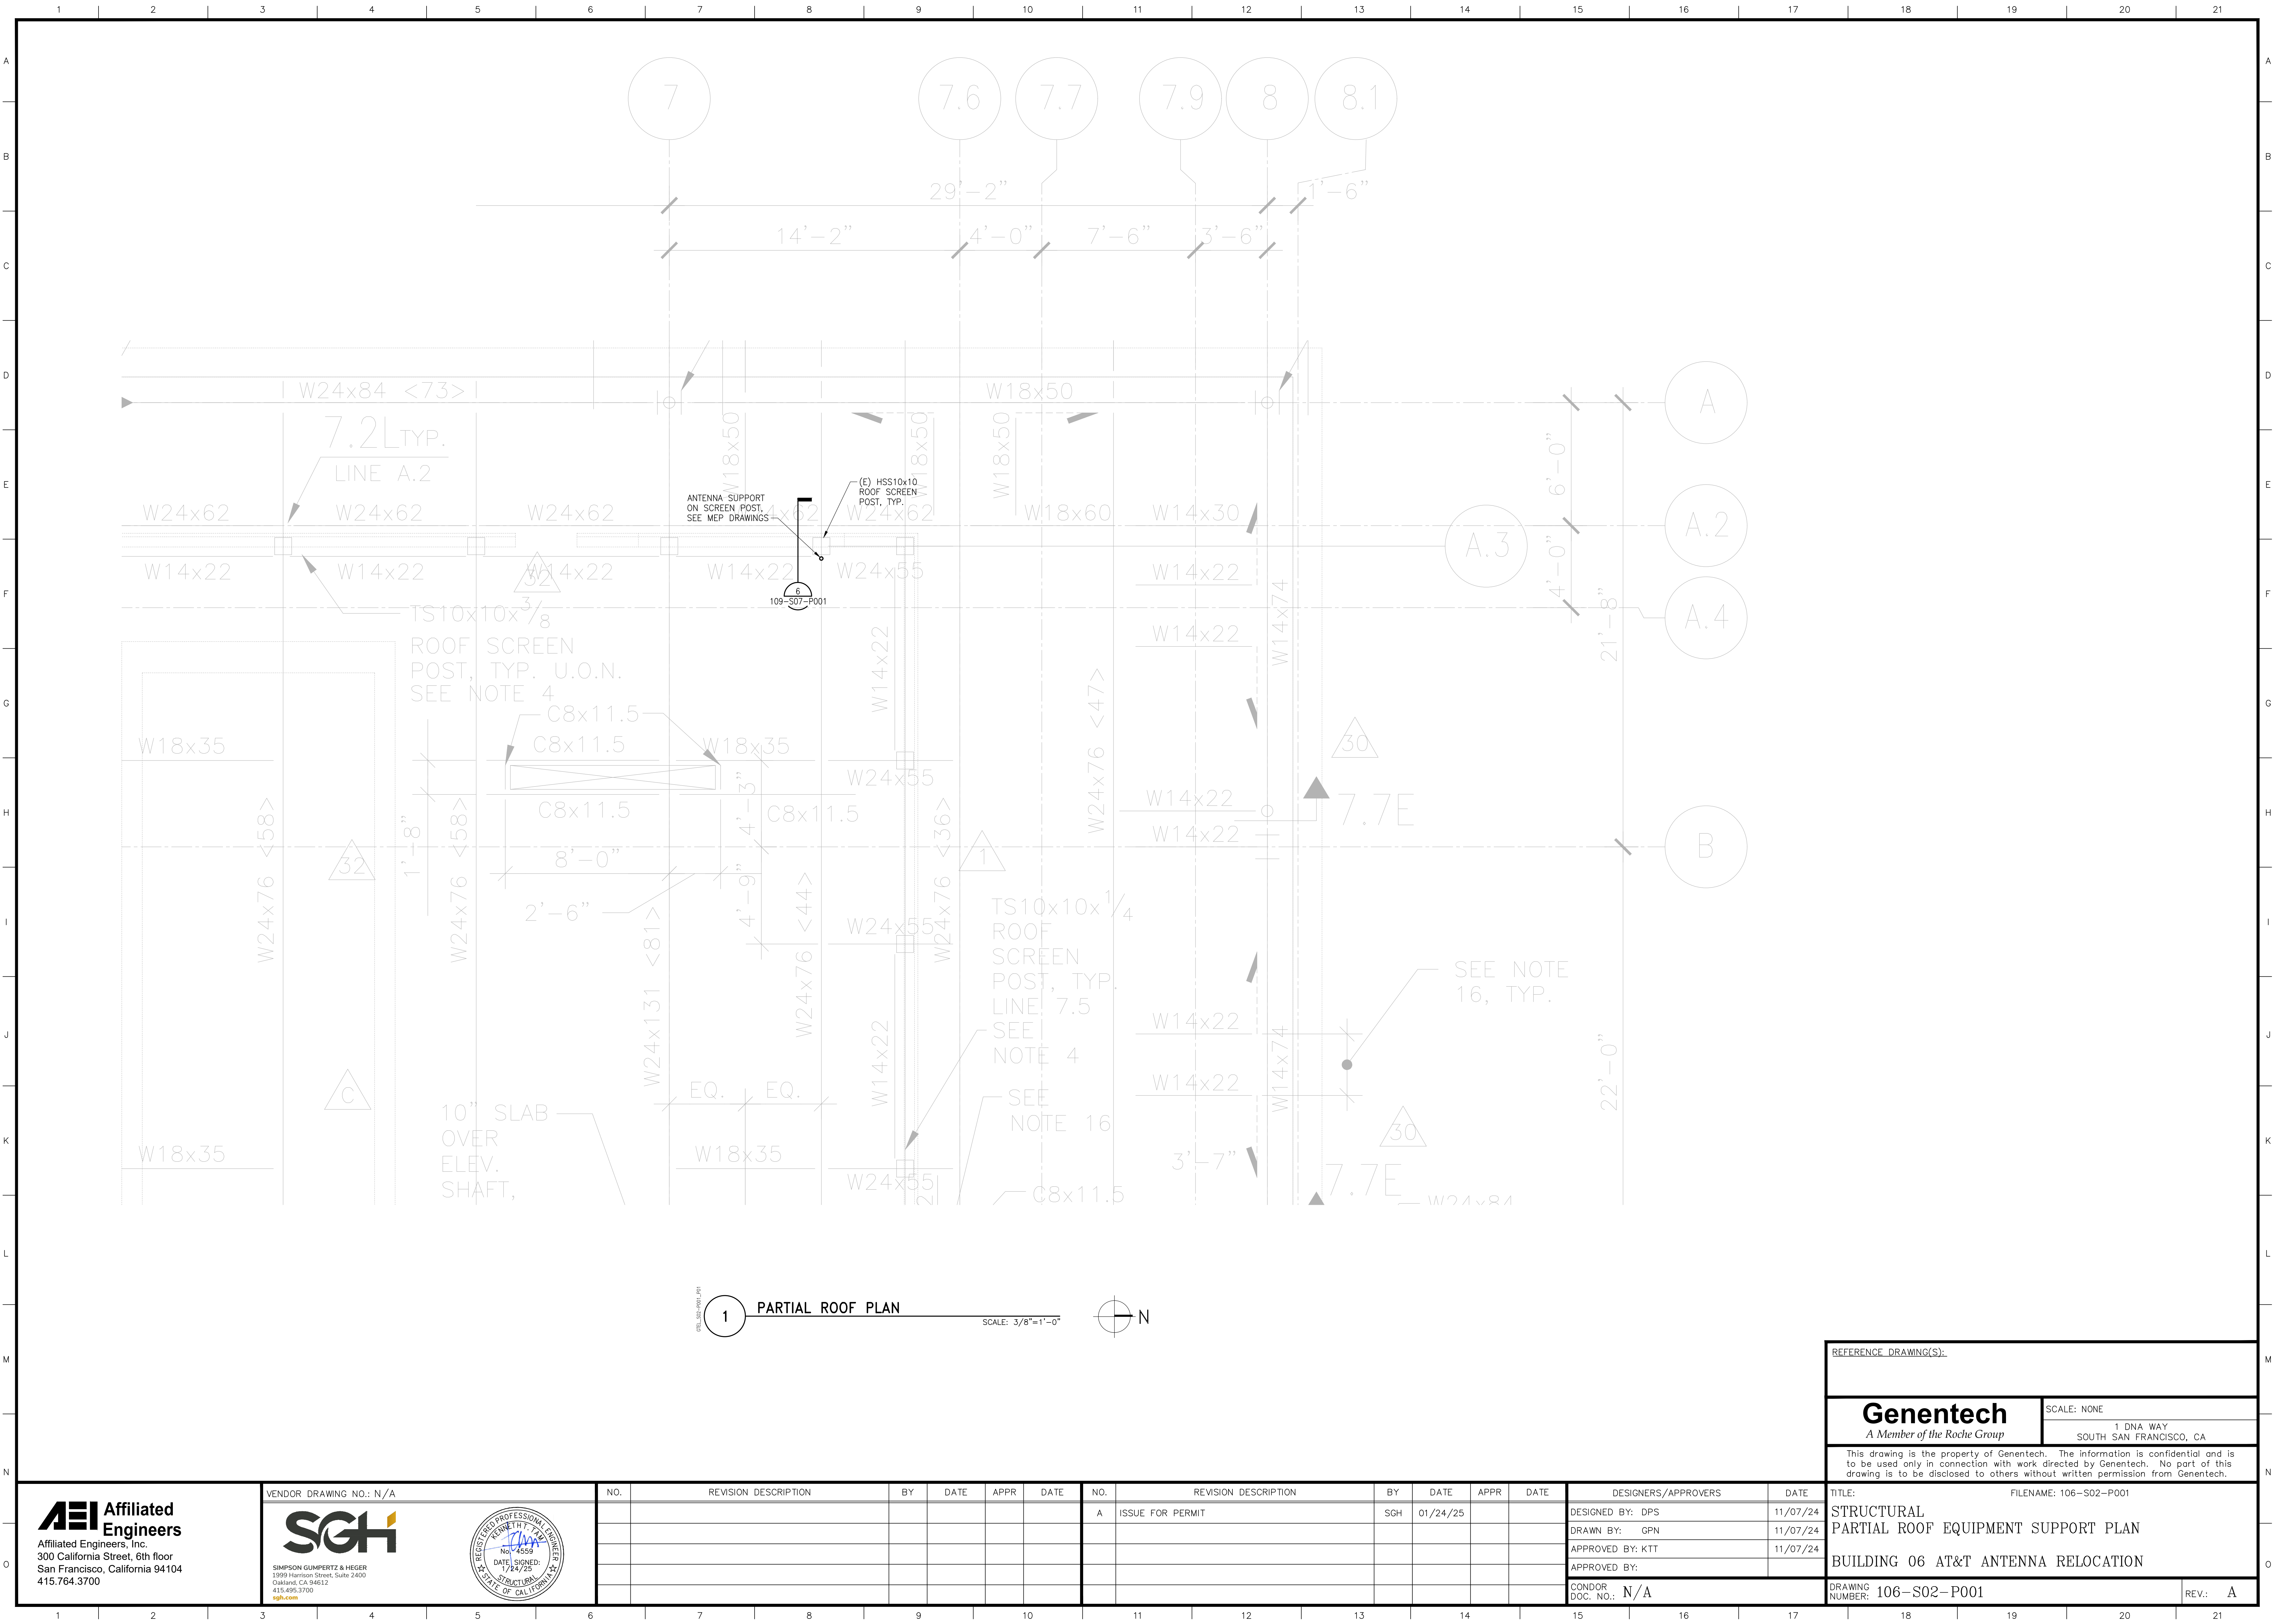

1 PARTIAL ROOF PLAN
SCALE: 3/8"=1'-0"

REFERENCE DRAWING(S):

Genentech

A Member of the Roche Group

SCALE: NONE
1 DNA WAY
SOUTH SAN FRANCISCO, CA

This drawing is the property of Genentech. The information is confidential and is to be used only in connection with work directed by Genentech. No part of this drawing is to be disclosed to others without written permission from Genentech.

FILENAME: 106-S02-P001

TITLE:	
STRUCTURAL PARTIAL ROOF EQUIPMENT SUPPORT PLAN	
BUILDING 06 AT&T ANTENNA RELOCATION	
DRAWING NUMBER: 106-S02-P001	REV.: A

VENDOR DRAWING NO.: N/A

SGH

SIMPSON GUMPERTZ & HEGER
1999 Harrison Street, Suite 2400
Oakland, CA 94612
415.495.3700
sghe.com

REGISTERED PROFESSIONAL ENGINEER

No. 4559

DATE SIGNED: 1/24/25


STRUCTURAL

STATE OF CALIFORNIA

NO.	REVISION DESCRIPTION	BY	DATE	APPR	DATE

NO.	REVISION DESCRIPTION	BY	DATE	APPR	DATE
A	ISSUE FOR PERMIT	SGH	01/24/25		

DESIGNERS/APPROVERS	DATE
DESIGNED BY: DPS	11/07/24
DRAWN BY: GPN	11/07/24
APPROVED BY: KTT	11/07/24
APPROVED BY:	
CONDOR DOC. NO.: N/A	

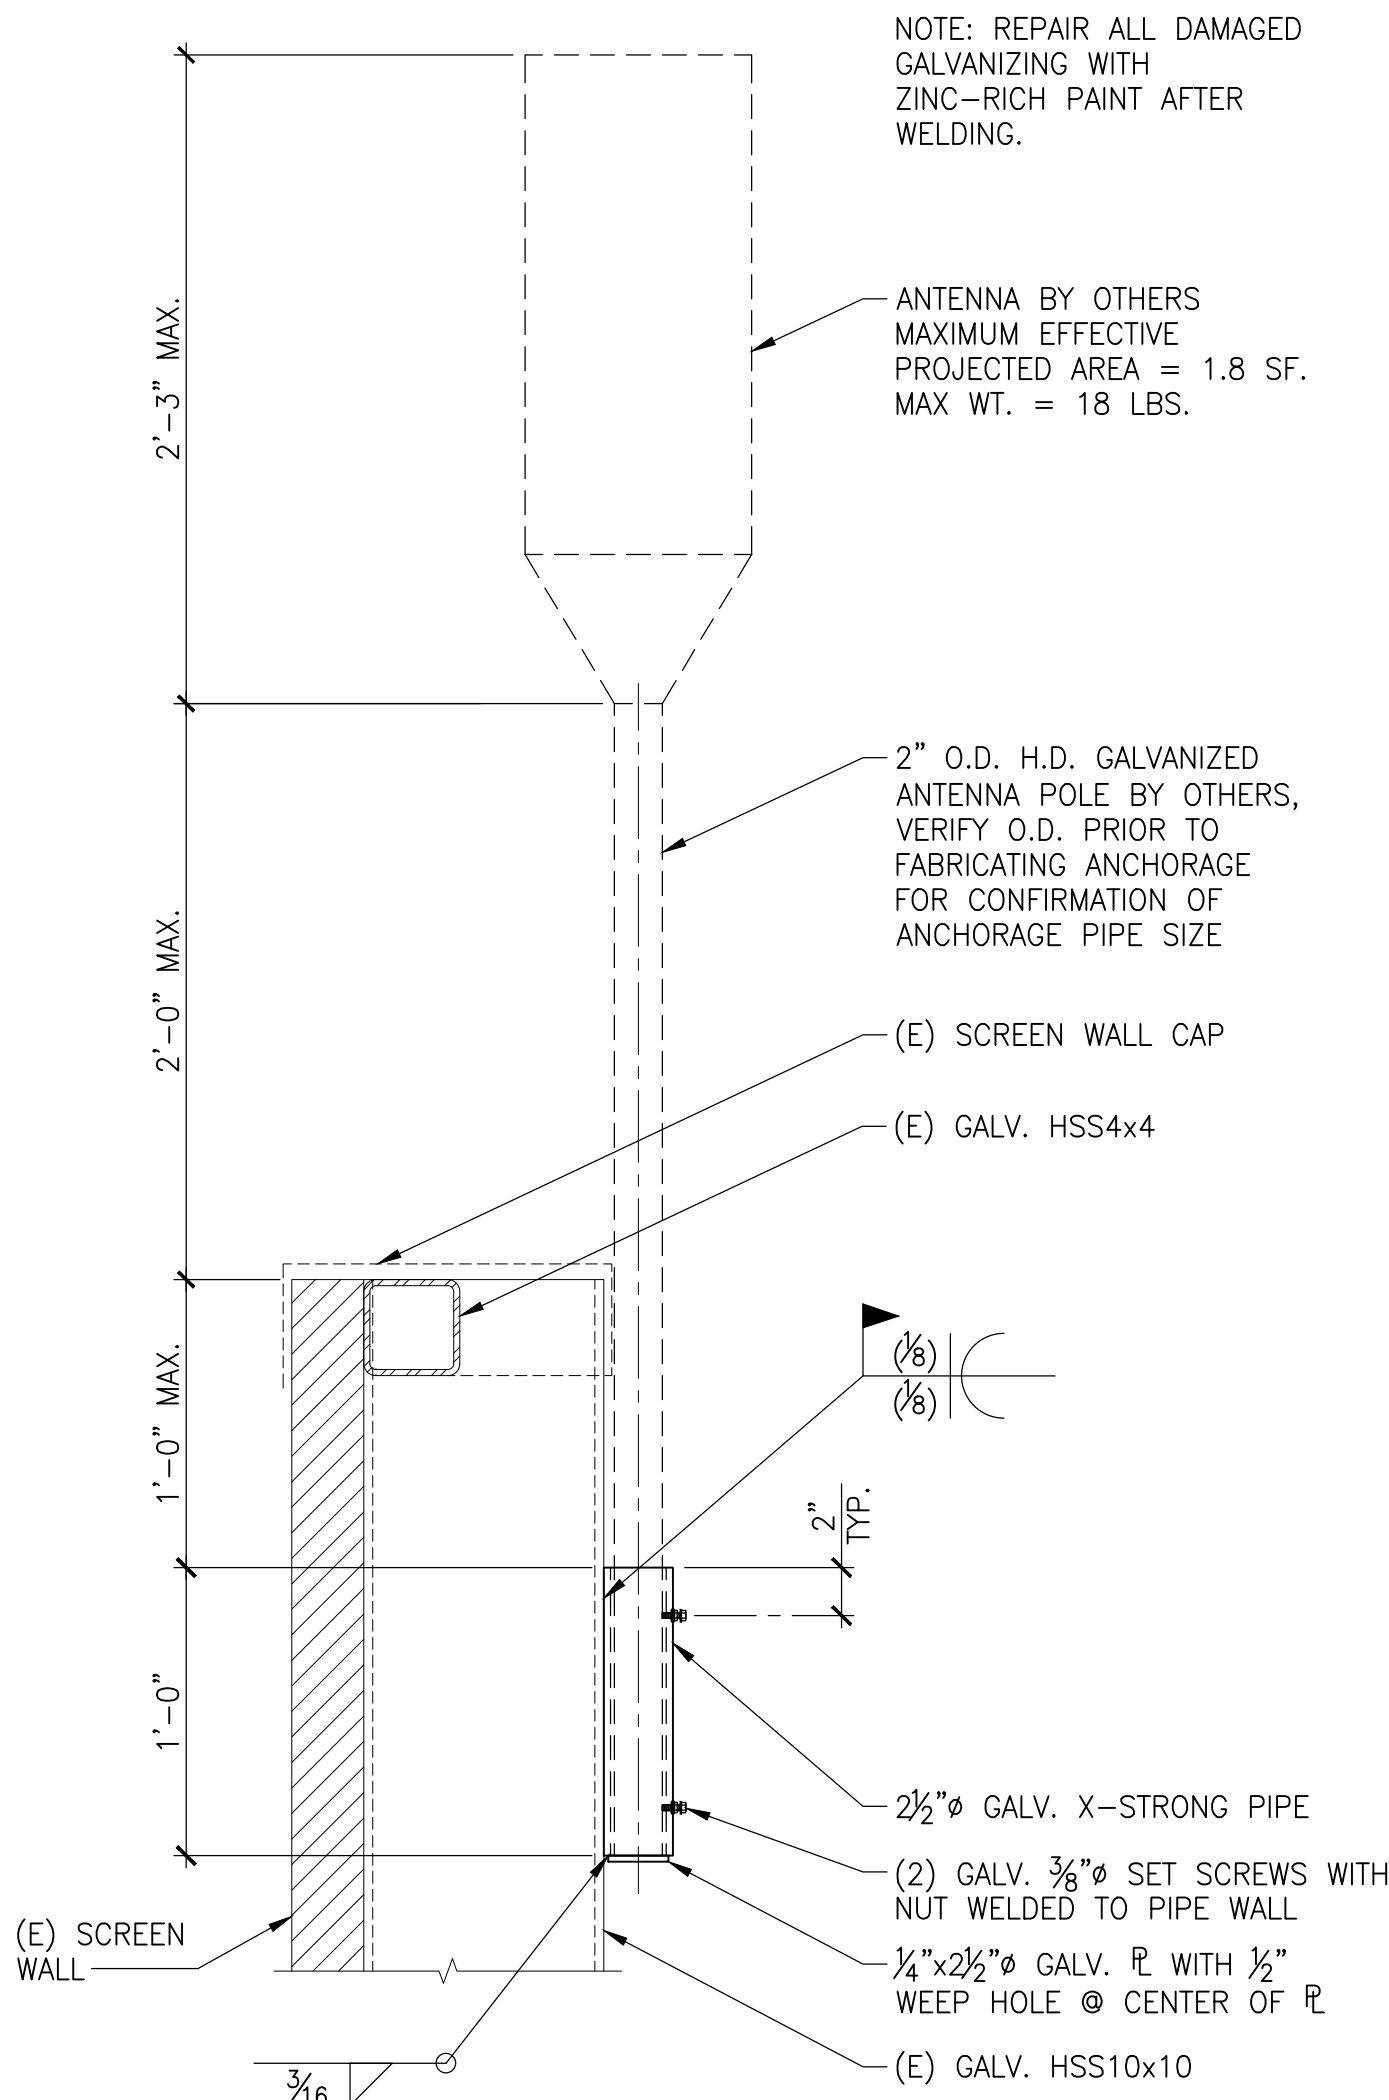

6 ANTENNA POLE ANCHORAGE DETAIL
AT TOP OF SCREEN WALL SCALE: 1 1/2"=1'-0"

REFERENCE DRAWING(S):

Genentech

A Member of the Roche Group

SCALE: NONE
1 DNA WAY
SOUTH SAN FRANCISCO, CA

This drawing is the property of Genentech. The information is confidential and is to be used only in connection with work directed by Genentech. No part of this drawing is to be disclosed to others without written permission from Genentech.

FILENAME: 106-S07-P001

VENDOR DRAWING NO.: N/A		NO.		REVISION DESCRIPTION		BY	DATE	APPR	DATE	NO.		REVISION DESCRIPTION		BY	DATE	APPR	DATE	DESIGNERS/APPROVERS		DATE	TITLE:		FILENAME: 106-S07-P001			
SGH SIMPSON GUMPERTZ & HEGER 1999 Harrison Street, Suite 2400 Oakland, CA 94612 415.495.3700 sght.com REGISTERED PROFESSIONAL ENGINEER GENE T. H. H. No. 4555 DATE SIGNED: 7/24/25 STRUCTURAL STATE OF CALIFORNIA											A	ISSUE FOR PERMIT		SGH	01/24/25			DESIGNED BY: DPS		08/28/24	STRUCTURAL DETAILS BUILDING 06 AT&T ANTENNA RELOCATION		DRAWING NUMBER: 106-S07-P001		REV.: A	
																	DRAWN BY: GPN		08/28/24							
																	APPROVED BY: KTT		08/28/24							
																			APPROVED BY:							
																			CONDOR DOC. NO.: N/A							

[illegible]